


6/15/2023 9:56:25 C:\Users\vmorris\OneDrive - Visioneering Studios\Documents\Roanoke-North\Roanoke Baptist Church_bmorris\RV091.rvt

ELECTRICAL ADDITIONAL POWER OUTLET FOR TV IN "ADULT 005" ADJUST CEILING LIGHTS WHERE "SERVICE 006" & ADJACENT KITCHEN ARE REMOVED.	MECHANICAL N/A	PLUMBING REMOVE & CAP EXISTING PLUMBING FIXTURES IN "SERVICE 006" REPLACE TOT TOILETS IN GANG RESTROOMS ACROSS HALL WITH ADULT SIZE TOILETS.
---	--------------------------	---

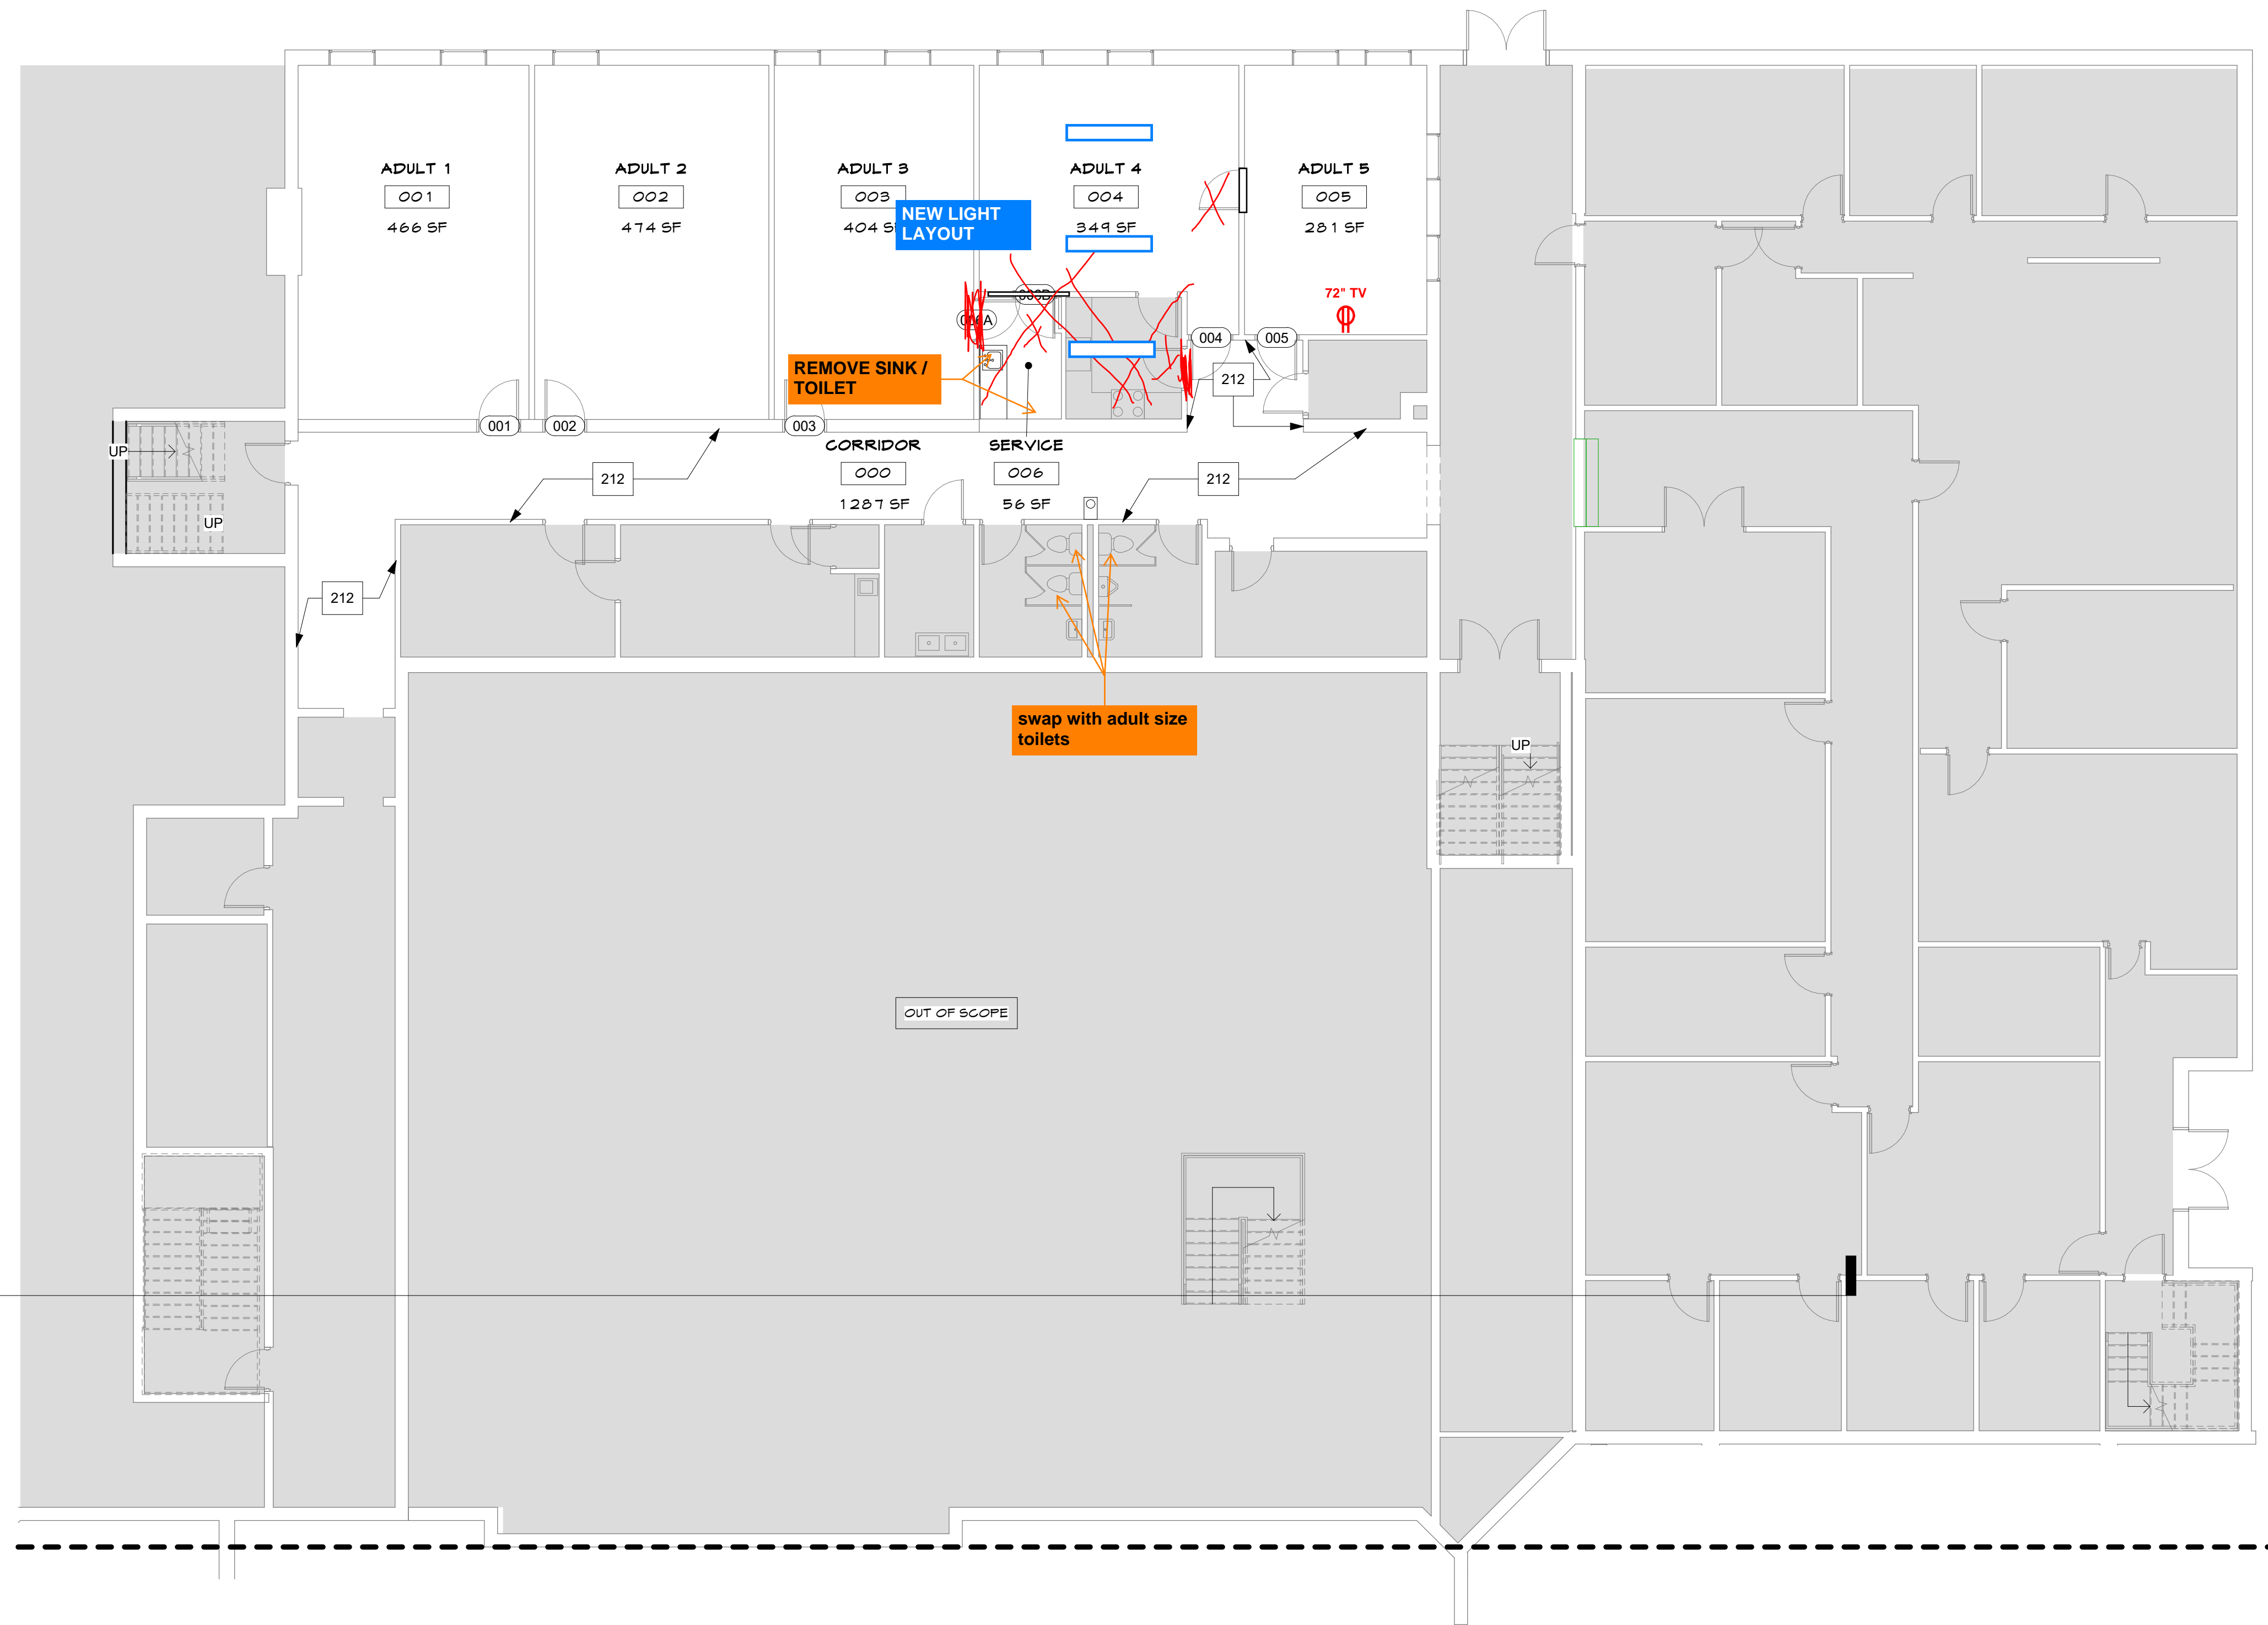

FLOOR PLAN LEGEND


- WALL LEGEND**
- INDICATES EXISTING WALLS / ELEMENTS
 - INDICATES PRE-ENGINEERED METAL WALL
 - INDICATES NEW CONSTRUCTION WALL
 - INDICATES NEW CMU WALL
 - INDICATES NEW CONSTRUCTION LOW WALLS
 - INDICATES NEW CONSTRUCTION WALLS BELOW OR ABOVE
 - INDICATES 1 HOUR RATING
 - INDICATES SOUND ATTENUATION
 - TV LOCATION. PROVIDE POWER & DATA. VERIFY HEIGHT WITH ARCHITECT. (MONITOR BY OWNER)
 - FIRE EXTINGUISHER (REFER TO SPECS.) PRIOR TO FIRE EXTINGUISHER INSTALLATION-CONFIRM LOCATIONS W/ FIRE DEPARTMENT
- FLOOR LEGEND**
- INDICATES RAISED FLOOR
 - INDICATES 3\"/>

FLOOR PLAN GENERAL NOTES


- 1 ALL DIMENSIONS ARE TO FACE OF MASONRY OR FACE OF METAL STUDS OR CENTER LINE OF STRUCTURAL STEEL U.O.N.
- 2 EXIT DOORS SHALL SWING IN THE DIRECTION OF EGRESS WHEN SERVING ANY OCCUPANT LOAD OF 50 OR MORE
- 3 INTERIOR WALLS ARE TYPE ___ U.O.N. SEE KEY PLAN FOR ALL OTHER PARTITION TYPES. REFER TO SHEET 2A.
- 4 REFER TO FLOOR PLAN ENLARGEMENT FOR DIMENSIONS NOT SHOWN
- 5 ALL DOORS SHALL BE LOCATED 4\"/>

FLOOR PLAN KEY NOTES

- 212 PAINT WALLS AND PLACE ALL REMOVED ITEMS IN ORIGINAL POSITIONS

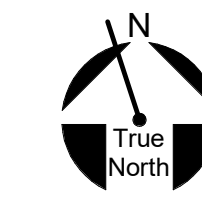

KEY PLAN

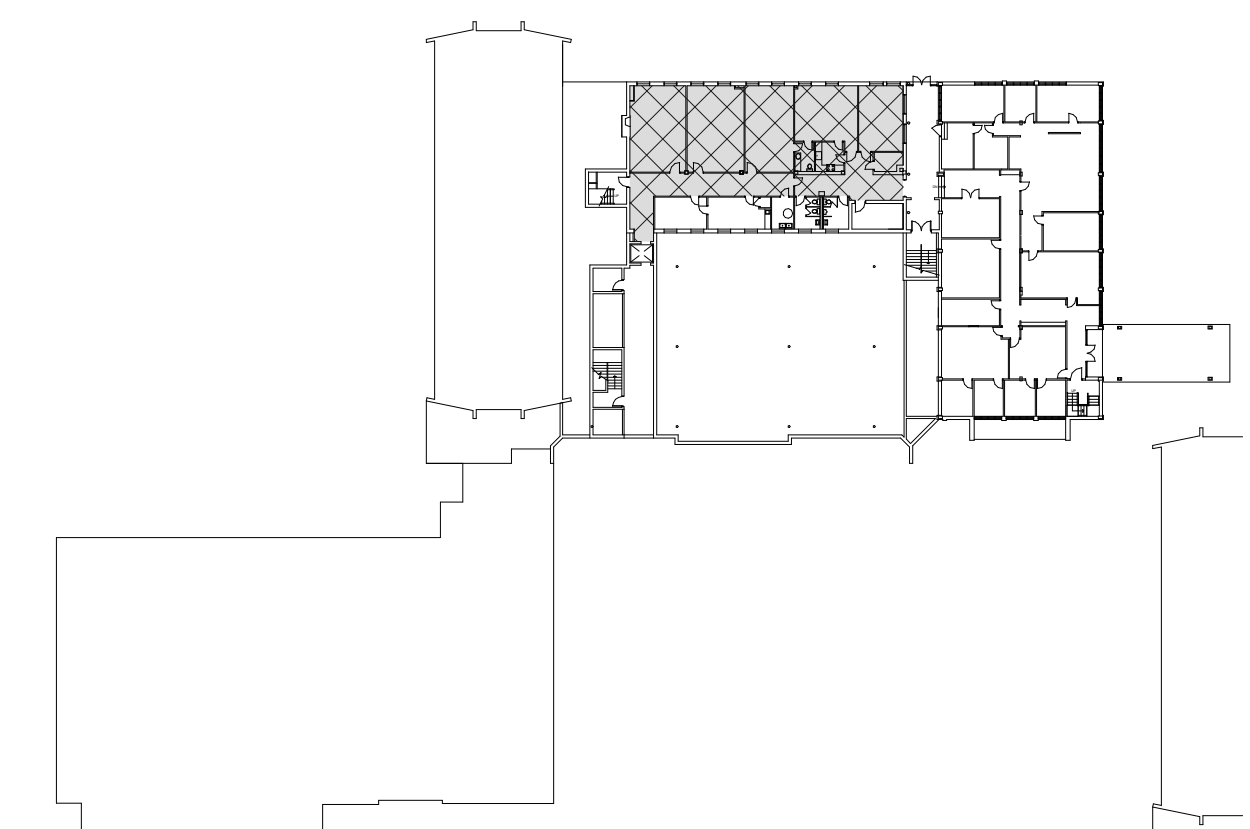

Seal

 Consultant

NORTH ROANOKE BAPTIST CHURCH
FACILITY RENOVATION
 6402 PETERS CREEK ROAD | ROANOKE, VA 24019

 GROUND FLOOR DIMENSION PLAN

SHEET ISSUE & REVISION		
#	DATE	DESCRIPTION

DESIGN TEAM	
Designed By	CC
Drawn By	TEAM
Checked By	BM
Approved By	BM
Project No.	23614
Date	06/06/23

Project Status
 SCHEMATIC DESIGN


 Sheet Name
 GROUND FLOOR DIMENSION PLAN

Sheet No.
A2.3

ELECTRICAL
 NEW POWER THROUGHOUT PER PLAN
 NEW LED TROFFERS IN CLASSROOMS. LARGE GROUP HOUSE LIGHTING BY AVL
 CONDUIT NEEDED FOR SECURITY CAMERAS

MECHANICAL
 MODIFICATION OF DISTRIBUTION IN PRE-K/NURSERY ROOMS PER NEW LAYOUT
 NEW RTU'S TO SERVE LARGE GROUP KIDS & BREAKOUT ROOMS SEPARATELY.

PLUMBING
 TOT TOILETS IN PRE-K ROOMS. ADULT EVERYWHERE ELSE. TANK TYPE TOILETS TYP.
 TOUCHLESS LAV FAUCETS THROUGHOUT
 PRE-K/NURSERY TIE TO NEARBY GANG RESTROOMS. ELEMENTARY FIXTURES SHALL HAVE NEW DRAIN LINE DIRECT OUT BUILDING & CONNECT IN PARKING LOT TO EXISTING.

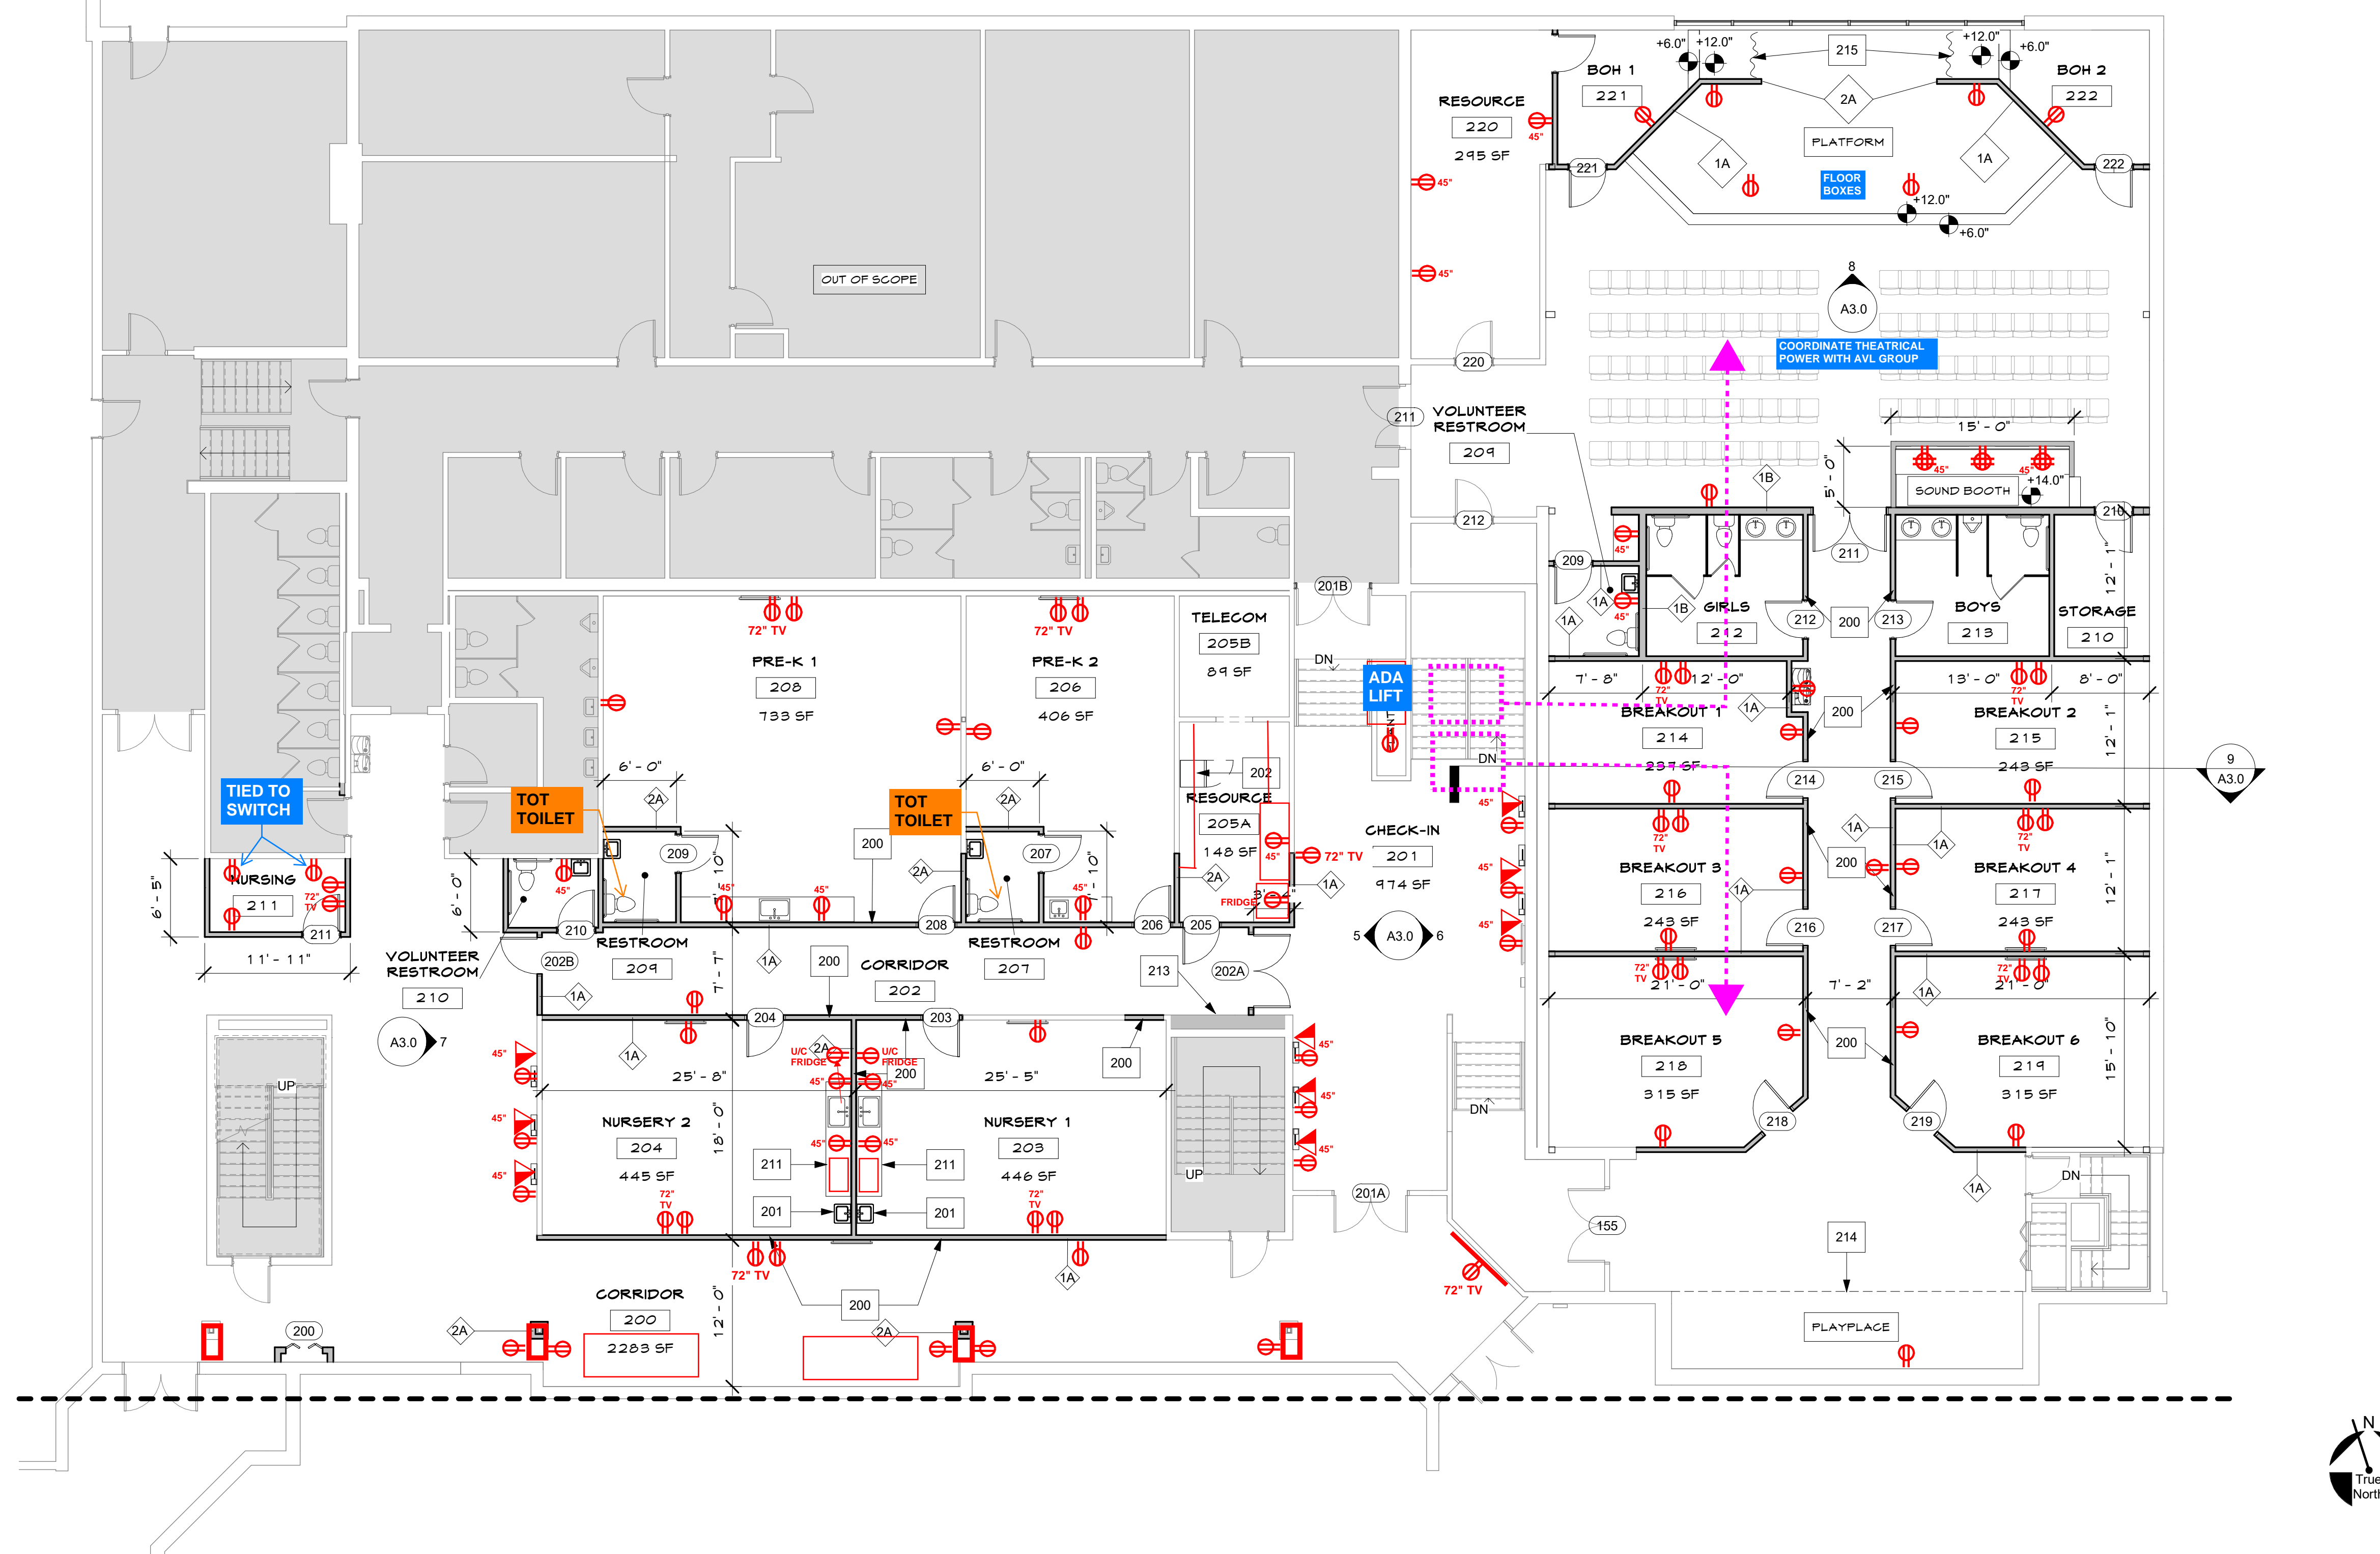

FLOOR PLAN LEGEND

- WALL LEGEND**
- INDICATES EXISTING WALLS / ELEMENTS
 - INDICATES PRE-ENGINEERED METAL WALL
 - INDICATES NEW CONSTRUCTION WALL
 - INDICATES NEW CMU WALL
 - INDICATES NEW CONSTRUCTION LOW WALLS
 - INDICATES NEW CONSTRUCTION WALLS BELOW OR ABOVE
 - INDICATES 1 HOUR RATING
 - INDICATES SOUND ATTENUATION
 - TV LOCATION. PROVIDE POWER & DATA. VERIFY HEIGHT WITH ARCHITECT. (MONITOR BY OWNER)
 - FIRE EXTINGUISHER (REFER TO SPECS.) PRIOR TO FIRE EXTINGUISHER INSTALLATION-CONFIRM LOCATIONS W/ ARCHITECT AND FIRE DEPARTMENT
- FLOOR LEGEND**
- INDICATES RAISED FLOOR
 - INDICATES 3" DEPRESSED SLAB TYPICAL AT KITCHEN AND RESTROOMS AS SHOWN ON PLANS
 - WHEELCHAIR SEATING LOCATION

FLOOR PLAN GENERAL NOTES

- ALL DIMENSIONS ARE TO FACE OF MASONRY OR FACE OF METAL STUDS OR CENTER LINE OF STRUCTURAL STEEL U/G
- EXIT DOORS SHALL SWING IN THE DIRECTION OF EGRESS WHEN SERVING ANY OCCUPANT LOAD OF 50 OR MORE
- INTERIOR WALLS ARE TYPE ... U/G. SEE KEY PLAN FOR ALL OTHER PARTITION TYPES. REFER TO SHEET 2A
- REFER TO FLOOR PLAN ENLARGEMENT FOR DIMENSIONS NOT SHOWN
- ALL DOORS SHALL BE LOCATED 4" FROM THE ADJACENT WALL, U/G, AND FLOOR PLAN ENLARGEMENT INFORMATION
- INTERIOR DIMENSIONS ARE TAKEN FROM THE FACE OF METAL STUDS
- REFER TO KEY PLANS FOR REFERENCES TO SECTIONS, DETAILS, TAGS, KEY NOTES, AND FLOOR PLAN ENLARGEMENT INFORMATION
- ADA CLEARANCES SUPERSEDE ALL DIMENSION ON PLANS AND SHOULD BE VERIFIED IN THE FIELD
- FOR DOOR TYPES, WINDOW TYPES AND MISCELLANEOUS DETAILS REFERENCES, SEE SHEET A4.1
- SEE INTERIOR DESIGN PLANS FOR ROOM FINISHES

FLOOR PLAN KEY NOTES

200	NEW FRAMED WALL - SEE WALL TYPES FOR THICKNESS.
201	WALL MOUNTED LAVATORY
202	UPRIGHT FREEZER & REFRIGERATOR - BY OWNER
211	NEW WALL MOUNTED COUNTERTOP AND SINK
213	INFILL AREA WITH STUDS AND DRYWALL MAKE FLUSH WITH EXISTING WALL
214	PLAY AREA EQUIPMENT PROVIDED BY OWNER
215	STAGE CURTAINS

VISIONEERING STUDIOS Architecture
 www.visioneeringstudios.com
 859 Riverside Drive
 Nashville, TN 37206

Seal
 Consultant

**NORTH ROANOKE BAPTIST CHURCH
 FACILITY RENOVATION**
 6402 PETERS CREEK ROAD | ROANOKE, VA 24019
 FIRST FLOOR PRE-K/KIDS DIMENSION PLAN

SHEET ISSUE & REVISION

#	DATE	DESCRIPTION

DESIGN TEAM

Designed By	CC
Drawn By	TEAM
Checked By	BM
Approved By	BM


Project No. 23614
 Date 06/06/23

Project Status
 SCHEMATIC DESIGN

Sheet Name
 FIRST FLOOR
 PRE-K/KIDS DIMENSION
 PLAN
 Sheet No.

A2.4

KEY PLAN

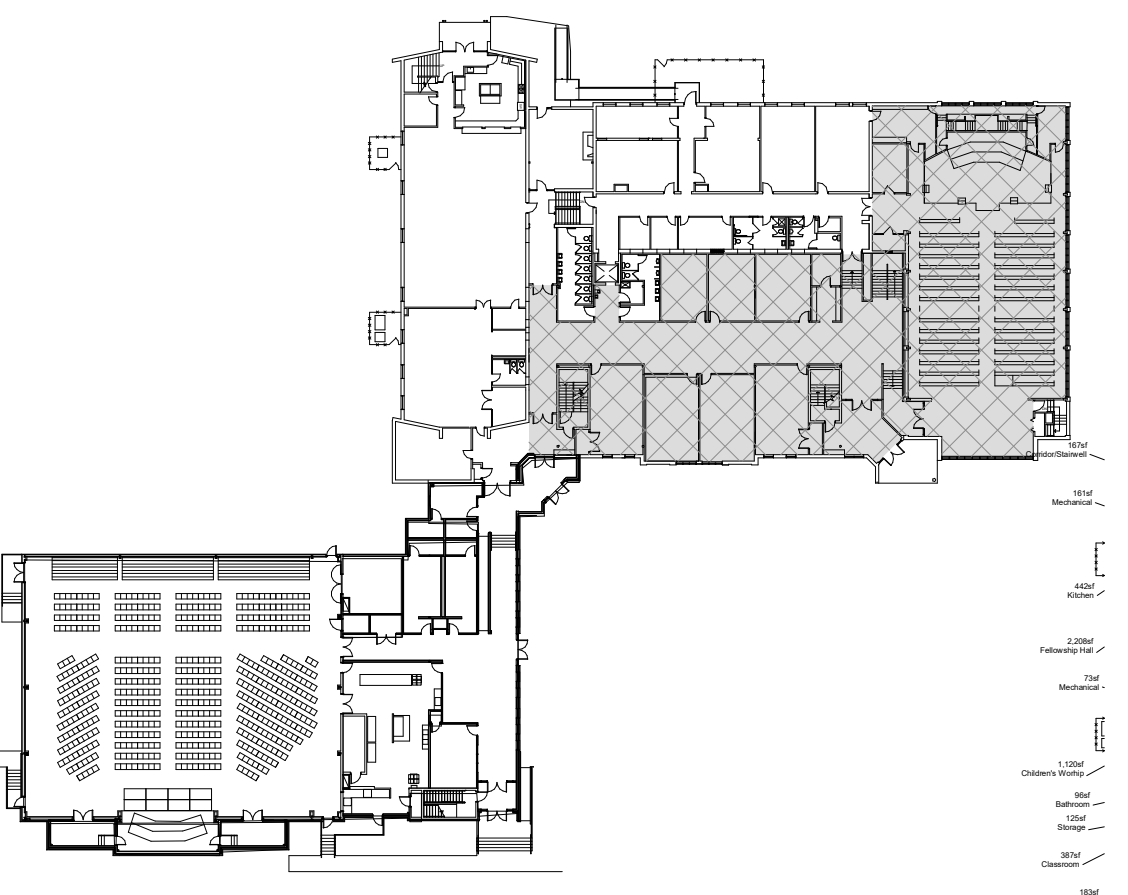


6/15/2023 9:56:26 C:\Users\vmorris\OneDrive - Visioneering Studios\Documents\Roanoke-North\Roanoke Baptist Church\bmorris\VA24019.rvt

6/15/2023 9:56:28 C:\Users\vmorris\OneDrive - Visioneering Studios\Documents\Roanoke-North\Roanoke Baptist Church\Church_bmorris\RVG91.rvt

ELECTRICAL
 NEW POWER THROUGHOUT PER PLAN
 NEW LED LIGHTING IN NEW WELCOME CENTER
 NEW SANCTUARY HOUSE LIGHTING BY AVL TO COEXIST W/ EXISTING GYM LIGHTING - COORDINATE J-BOX LOCATIONS

MECHANICAL
 MODIFICATION OF DISTRIBUTION IN KITCHEN / LOBBY PER NEW LAYOUT
 EXTENSION OF SUPPLY & RETURN DUCTS INTO NEW STORAGE AREAS

PLUMBING
 N/A

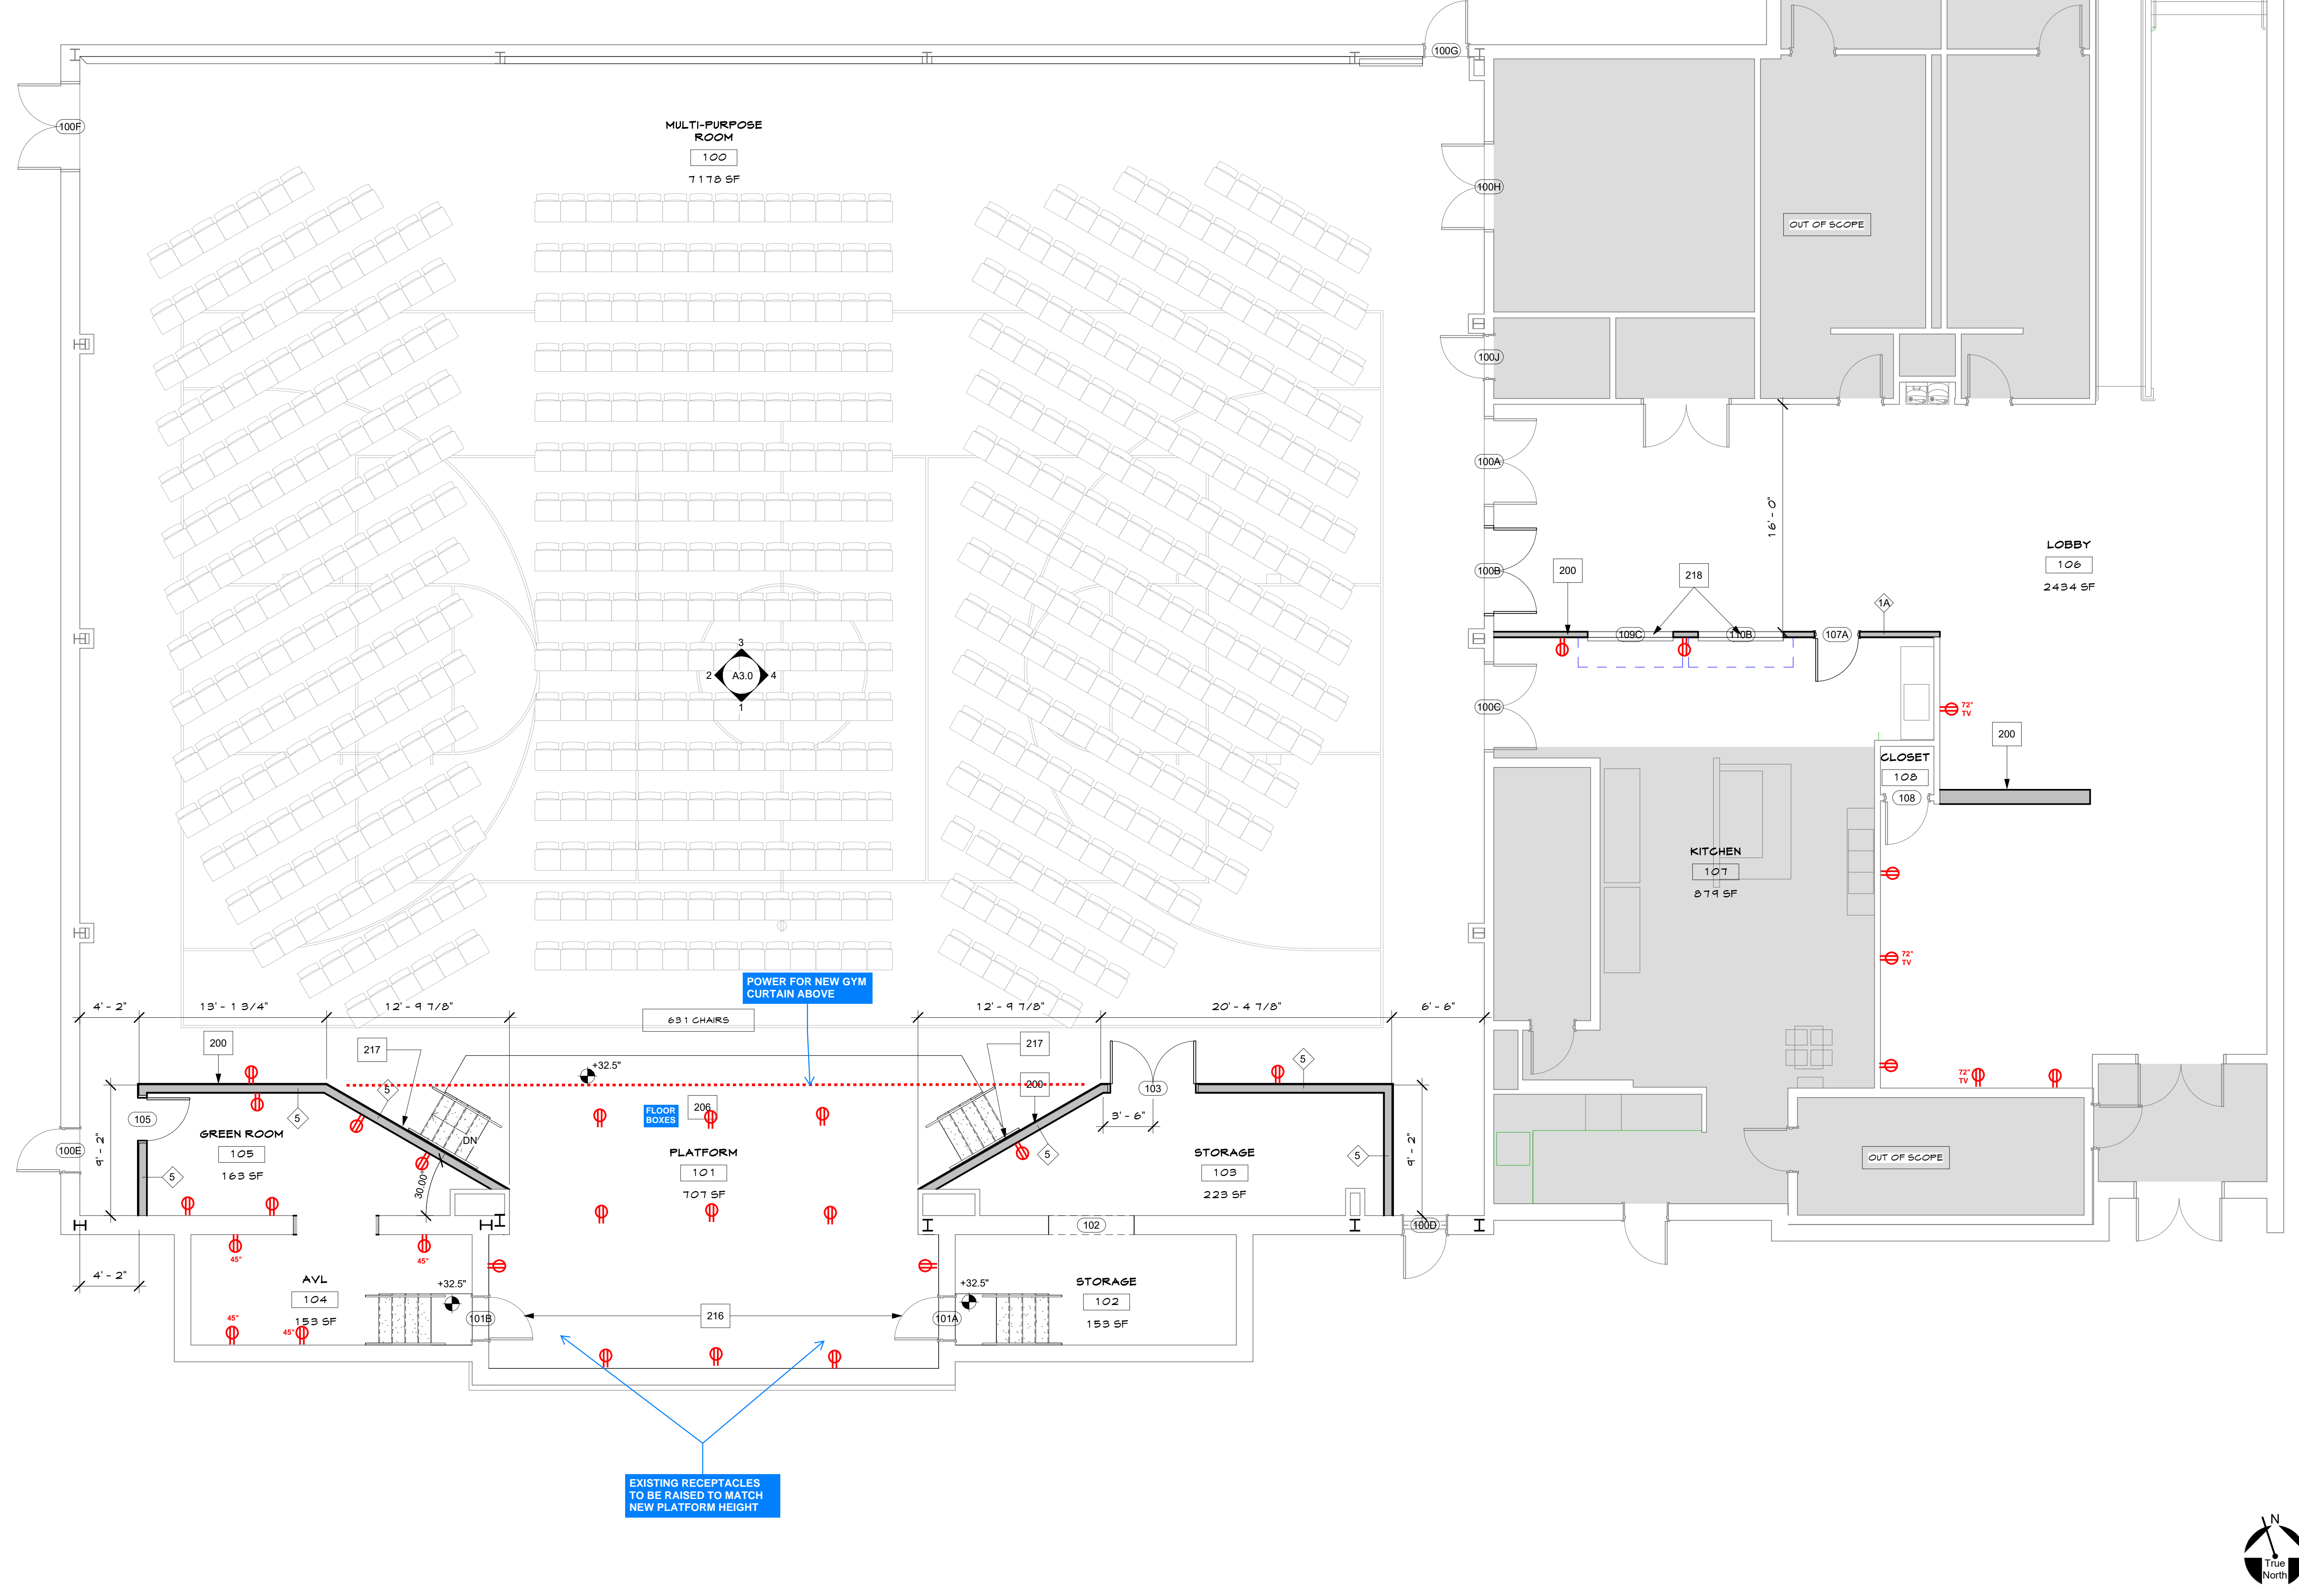

FLOOR PLAN LEGEND

- WALL LEGEND**
- INDICATES EXISTING WALLS / ELEMENTS
 - INDICATES PRE-ENGINEERED METAL WALL
 - INDICATES NEW CONSTRUCTION WALL
 - INDICATES NEW CMU WALL
 - INDICATES NEW CONSTRUCTION LOW WALLS
 - INDICATES NEW CONSTRUCTION WALLS BELOW OR ABOVE
 - INDICATES 1 HOUR RATING
 - INDICATES SOUND ATTENUATION
- FLOOR LEGEND**
- TV LOCATION. PROVIDE POWER & DATA. VERIFY HEIGHT WITH ARCHITECT. (MONITOR BY OWNER)
 - FIRE EXTINGUISHER (REFER TO SPEC.) PRIOR TO FIRE EXTINGUISHER INSTALLATION-CONFIRM LOCATIONS W/ "FLOOR LEGEND" FIRE DEPARTMENT
 - INDICATES RAISED FLOOR
 - INDICATES 3" DEPRESSED SLAB TYPICAL AT KITCHEN AND RESTROOMS AS SHOWN ON PLANS
 - WHEELCHAIR SEATING LOCATION


FLOOR PLAN GENERAL NOTES

- 1 ALL DIMENSIONS ARE TO FACE OF MASONRY OR FACE OF METAL STUDS OR CENTER LINE OF STRUCTURAL STEEL U.O.N.
- 2 EXIT DOORS SHALL SWING IN THE DIRECTION OF EGRESS WHEN SERVING ANY OCCUPANT LOAD OF 50 OR MORE.
- 3 INTERIOR WALLS ARE TYPE _____ U.O.N. SEE KEY PLAN FOR ALL OTHER PARTITION TYPES. REFER TO SHEET 2A.
- 4 REFER TO FLOOR PLAN ENLARGEMENT FOR DIMENSIONS NOT SHOWN.
- 5 ALL DOORS SHALL BE LOCATED 4" FROM THE ADJACENT WALL U.O.N.
- 6 INTERIOR DIMENSIONS ARE TAKEN FROM THE FACE OF METAL STUDS.
- 7 REFER TO KEY PLANS FOR REFERENCES TO SECTIONS, DETAILS, TAGS, KEY NOTES, AND FLOOR PLAN ENLARGEMENT INFORMATION.
- 8 ADA CLEARANCES SUPERSEDE ALL DIMENSION ON PLANS AND SHOULD BE VERIFIED IN THE FIELD.
- 9 FOR DOOR TYPES, WINDOW TYPES AND MISCELLANEOUS DETAILS REFERENCES, SEE SHEET A-1.
- 10 SEE INTERIOR DESIGN PLANS FOR ROOM FINISHES.

FLOOR PLAN KEY NOTES

- 200 NEW FRAMED WALL - SEE WALL TYPES FOR THICKNESS.
- 209 PLYWOOD PLATFORM OVER STEEL FRAMING, SEE STRUCTURAL PLANS AND DETAILS 9/A2.
- 216 RAISE DOORS TO PLATFORM ELEVATION SEE PLANS
- 217 LARGE SCREEN
- 218 ROLL-UP SERVING DOORS

FLOOR PLAN KEY PLAN

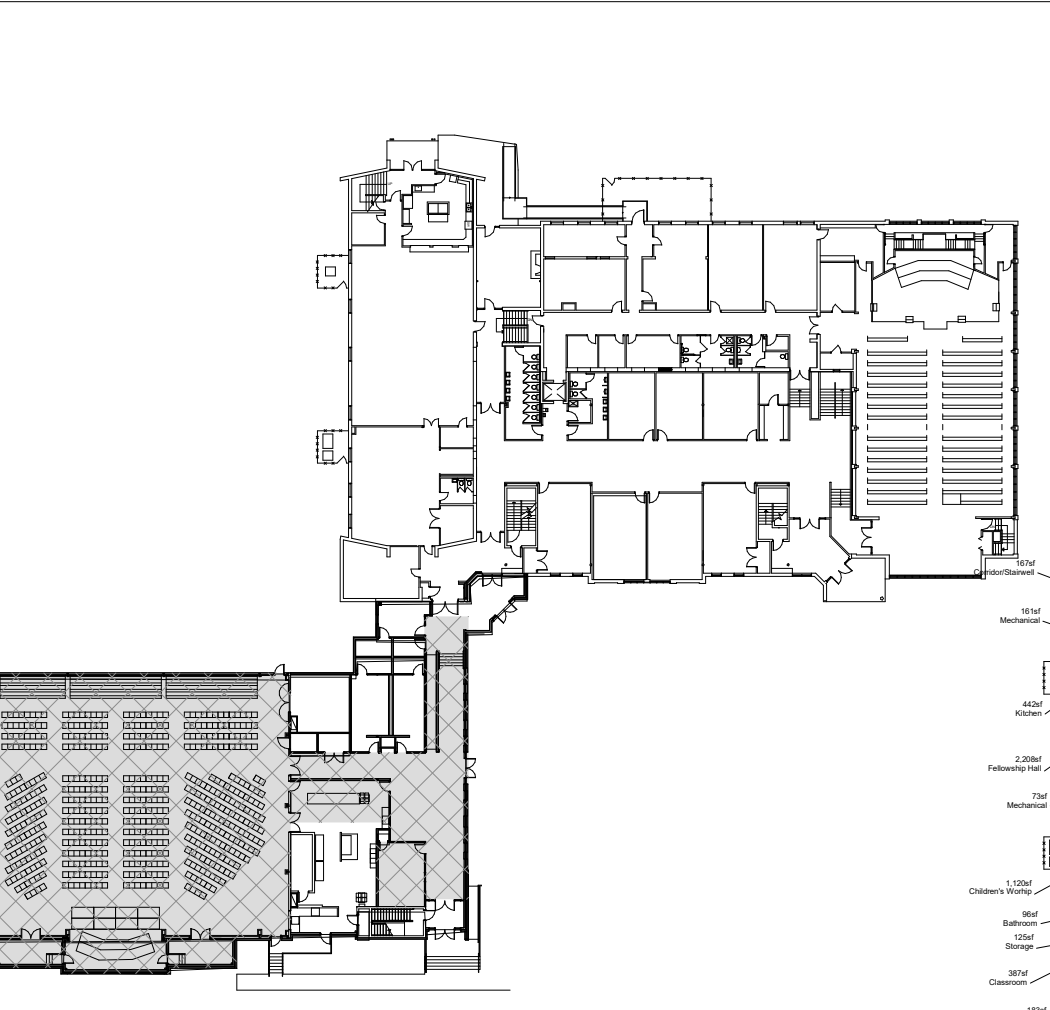

VISIONEERING STUDIOS Architecture
 www.visioneeringstudios.com
 859 Riverside Drive
 Nashville, TN 37206

Seal
 Consultant

**NORTH ROANOKE BAPTIST CHURCH
 FACILITY RENOVATION**
 6402 PETERS CREEK ROAD | ROANOKE, VA 24019
 FIRST FLOOR GYM DIMENSION PLAN

SHEET ISSUE & REVISION

#	DATE	DESCRIPTION

DESIGN TEAM

Designed By	CC
Drawn By	TEAM
Checked By	BM
Approved By	BM
Project No.	23614
Date	06/06/23


Project Status
 SCHEMATIC DESIGN

Sheet Name
 FIRST FLOOR GYM DIMENSION PLAN

Sheet No.
A2.5

6/15/2023 9:56:28 C:\Users\vmorris\OneDrive - Visioneering Studios\Documents\Roanoke\Roanoke Baptist Church\Church_bmorrisRV091.rvt

1 / A4.1

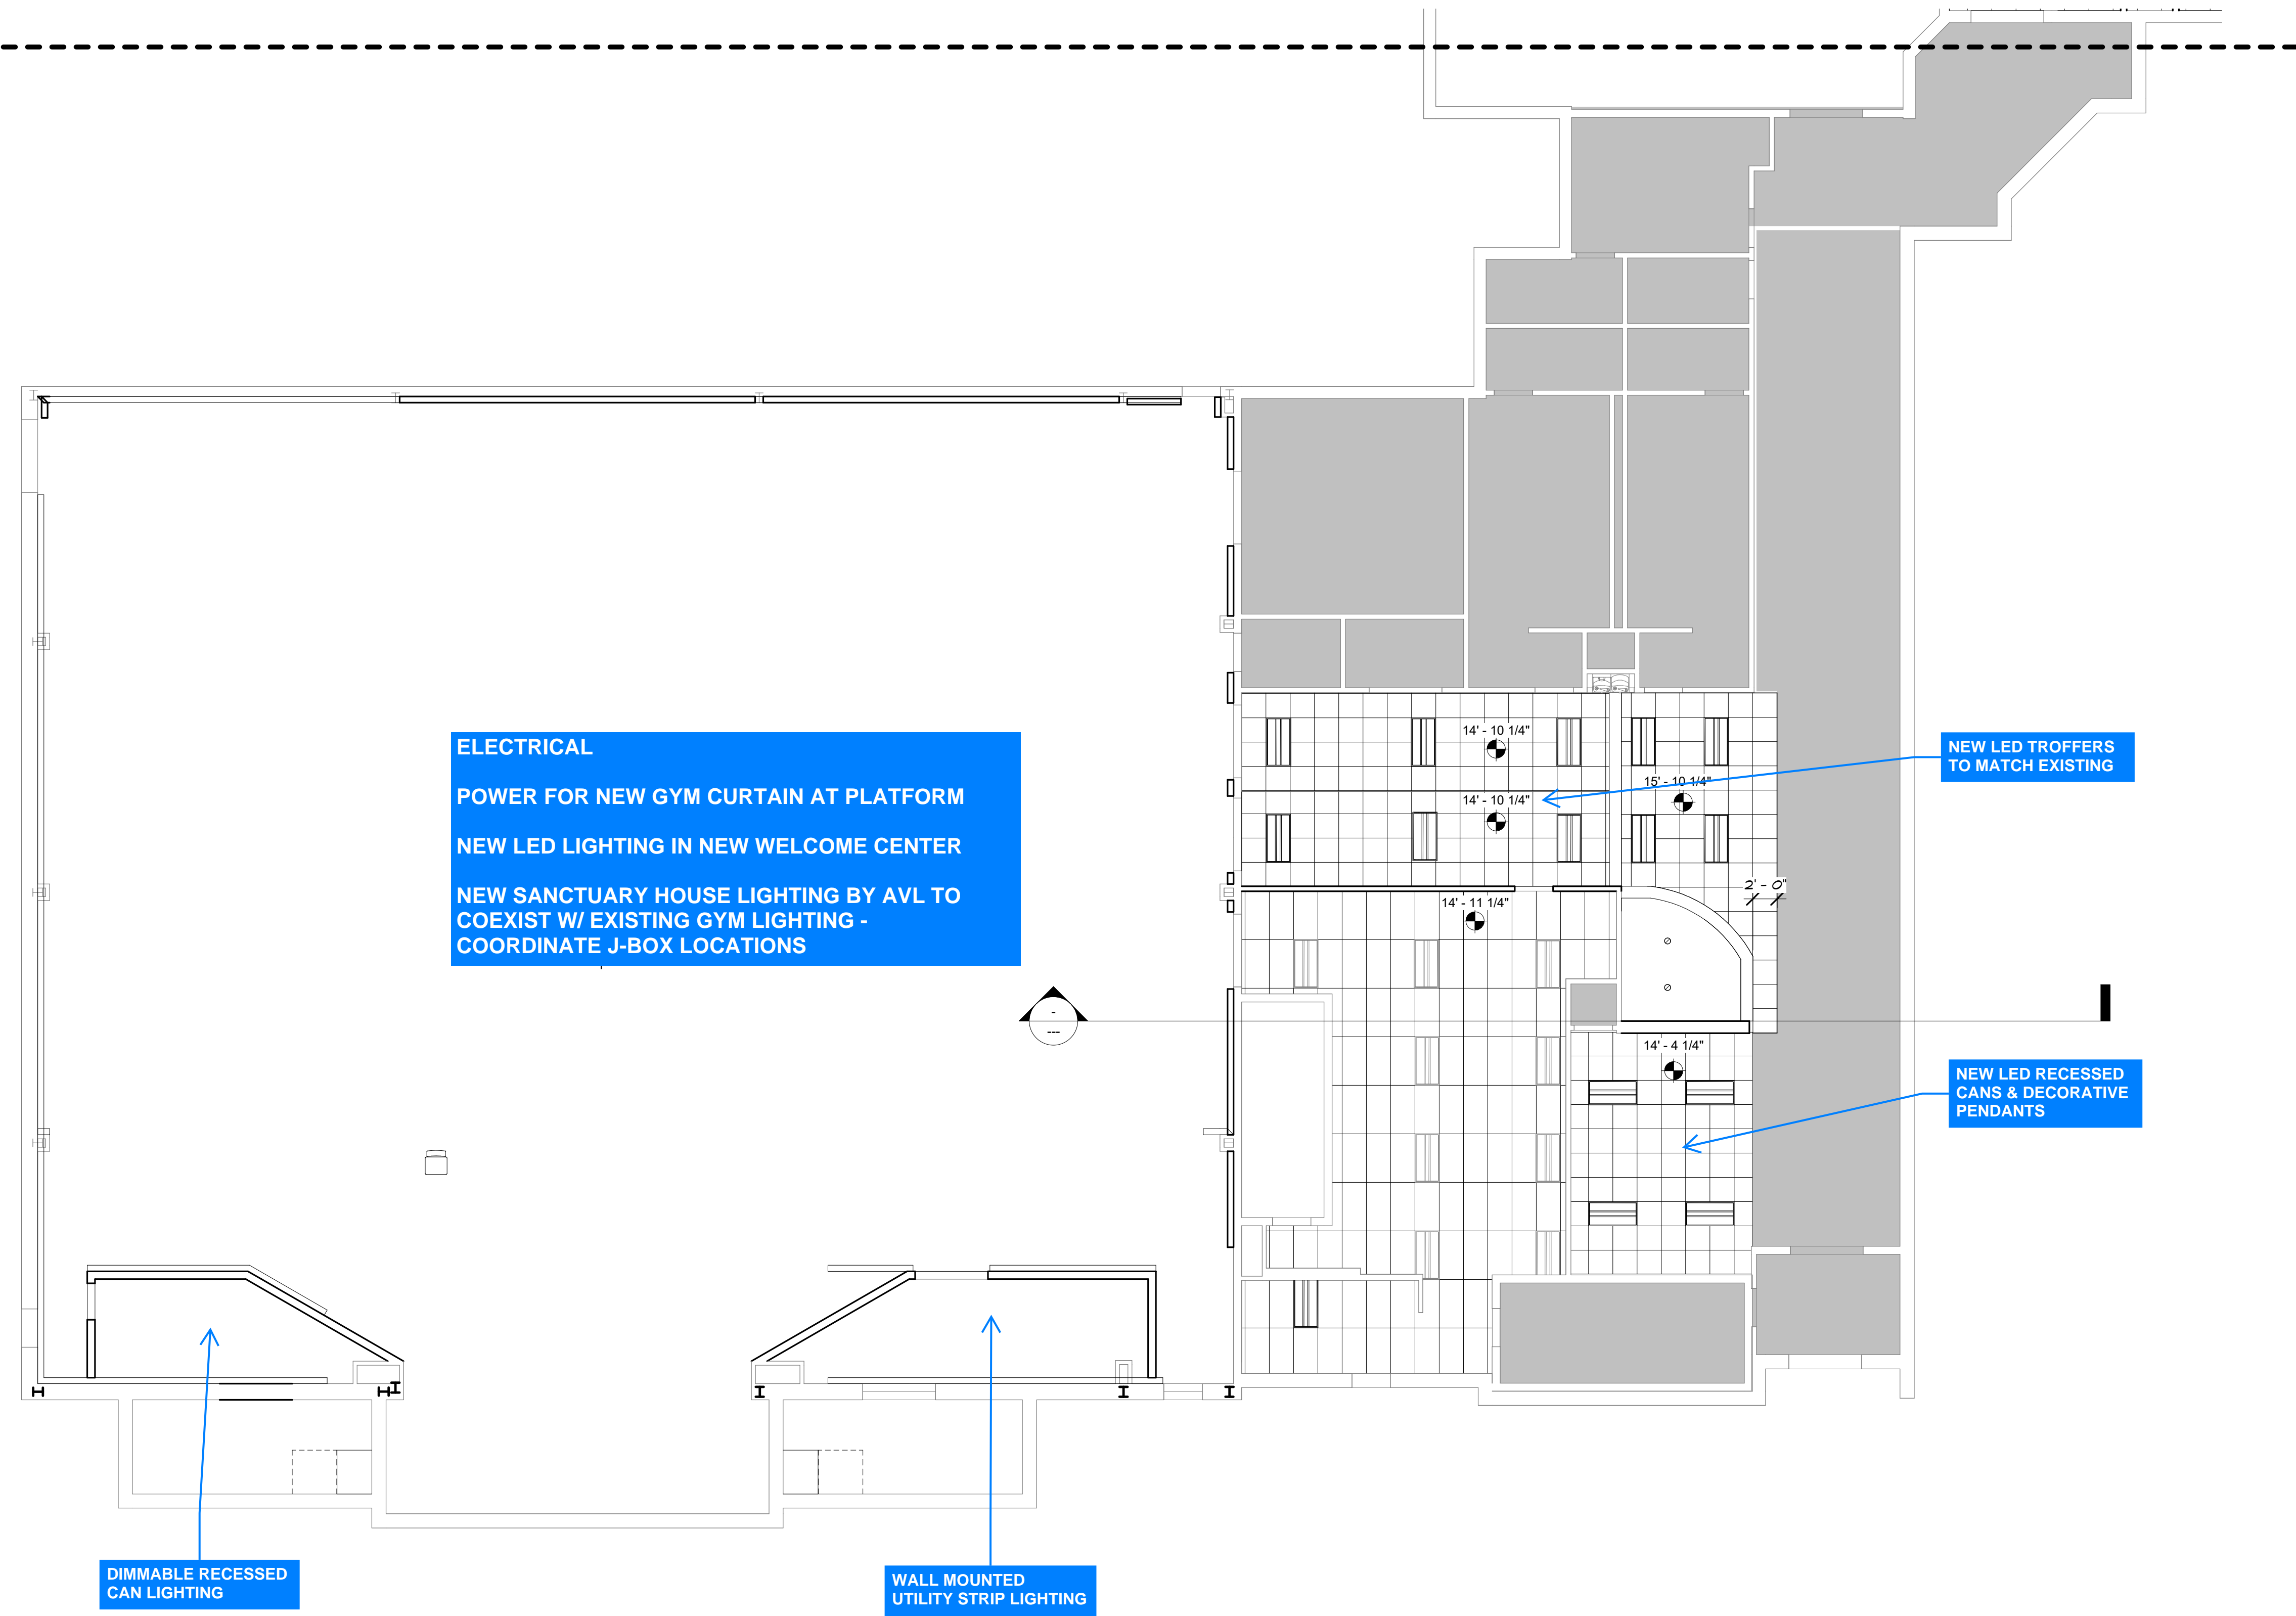

RCP LEGEND

- LIGHTING**
- ⊙ RECESSED CAN (LED)
 - ⊙ SUSPENDED PENDANT (LED)
 - 1X4 FIXTURE (LED)
 - ▨ 2X2 RECESSED (LED)
- CEILING**
- OPEN CEILING TO STRUCTURE ABOVE
 - ▨ DRYWALL
 - ▨ SMOOTH TEXTURED EIFS OVER 1/2\" THK DENS GOLD SUBSTRATE 1/2\" THK CEMENT BOARD SUBSTRATE, TYP. @ OUTSIDE SOFFIT CONDITION
 - ▨ EXTERIOR CONDITION SMOOTH TEXTURED EIFS OVER 1/2\" THK DENS GOLD SUBSTRATE 1/2\" THK CEMENT BOARD, TYP. @ OUTSIDE SOFFIT CONDITION
 - ▨ MFG: ARMSTRONG 24\" X 24\" DUNE, REGULAR SUSPENSION GRID: 15\"/16\" P/RELUDE/WHITE
 - ⊙ 6\" x 6\" SUSPENDED CLOUDS @ VARIOUS HEIGHTS/ARMSTRONG FORMATIONS // WOODWORKS TILE AND AXIOM PERIMETER TRIM
 - ⊙-X'-X\" INDICATES CEILING HEIGHTS
 - ⊙-P/A INDICATES PAINT
 - ⋯ INDICATES SOUND ATTENUATION
- MECHANICAL/ HVAC**
(FOR REFERENCE ONLY - REFER TO MECHANICAL DRAWINGS FOR SPECIFIC INFORMATION)
- ⊗ SUPPLY AIR REGISTER
 - ⊘ RETURN AIR REGISTER
 - ⊗ EXHAUST AIR REGISTER
 - ⊙ SPEAKER AND CONTROL, REFER TO AUDIO/VIDEO PLANS
- EXIT SIGNS**
- ⊗ WALL/CEILING MOUNTED EXIT SIGN ABOVE DOOR (SEE ELECTRICAL - TYPICAL) PER SECT. 1019.1/2015 IBC
 - ⊗ ALUMINUM STOREFRONT MOUNTED EXIT SIGN (SEE ELECTRICAL DRAWINGS - TYPICAL) PER SECT. 1019.1/2015 IBC

RCP SPECIFICATIONS

RCP GENERAL NOTES

- 1 SUSPENDED CEILING SYSTEM - TYP GRID SYSTEM, REFER TO RCP DETAIL SHEET
- 2 LOCATE ALL LIGHTING FIXTURES AS SHOWN ON PLAN. ALIGN AT SOFFITS OR ROOMS AND PLACE EQUALLY SPACED AS SHOWN. REFER TO ELECTRICAL PLANS FOR ADDITIONAL INFORMATION.
- 3 ALL OPEN CEILING TO BE PAINTED (COLOR CHOSEN BY ARCHITECT), TO INCLUDE ALL SURFACES, EXPOSED CONDUIT, FIRE SPRINKLER LINES, AIR DUCTS, SUPPLY AND RETURN AIR GRILLES, ETC. STARTING AT THE BOTTOM OF LOWEST STRUCTURAL ELEMENT (UNLESS OTHERWISE NOTED). SEE PAINT SCHEDULE.
- 4 LOCATE ALL LIGHTING FIXTURES AS SHOWN, AND PER DIMENSIONS ON PLANS. COORDINATE WITH CONSTRUCTION DOCUMENTS FROM ASSOCIATED DISCIPLINES.
- 5 THEATRICAL/STAGE LIGHTING IN SANCTUARY/ASSEMBLY ROOMS TO BE SELECTED AND LOCATED BY AUDIO VISUAL CONSULTANT AND ELECTRICAL ENGINEER. COORDINATE WITH ALL DISCIPLINES BEFORE CONSTRUCTION.
- 6 REFER TO INTERIOR DESIGN PLANS FOR ADDITIONAL INFORMATION REGARDING PAINT, FINISH MATERIALS, ETC.

RCP KEY NOTES



www.visioneeringstudios.com
859 Riverside Drive
Nashville, TN 37206

Seal

Consultant

NORTH ROANOKE BAPTIST CHURCH
FACILITY RENOVATION
6402 PETERS CREEK ROAD | ROANOKE, VA 24019

REFLECTED CEILING GYM

SHEET ISSUE & REVISION

#	DATE	DESCRIPTION

DESIGN TEAM

Designed By	CC
Drawn By	TEAM
Checked By	BM
Approved By	BM

Project No. 23614

Date 06/06/23

Project Status

SCHEMATIC DESIGN


Sheet Name
REFLECTED CEILING GYM

Sheet No.


A4.0



6/15/2023 9:56:24 C:\Users\vmorris\OneDrive - Visioneering Studios\Documents\Roanoke\North Roanoke Baptist Church\Church_bmorris\VA91.rvt

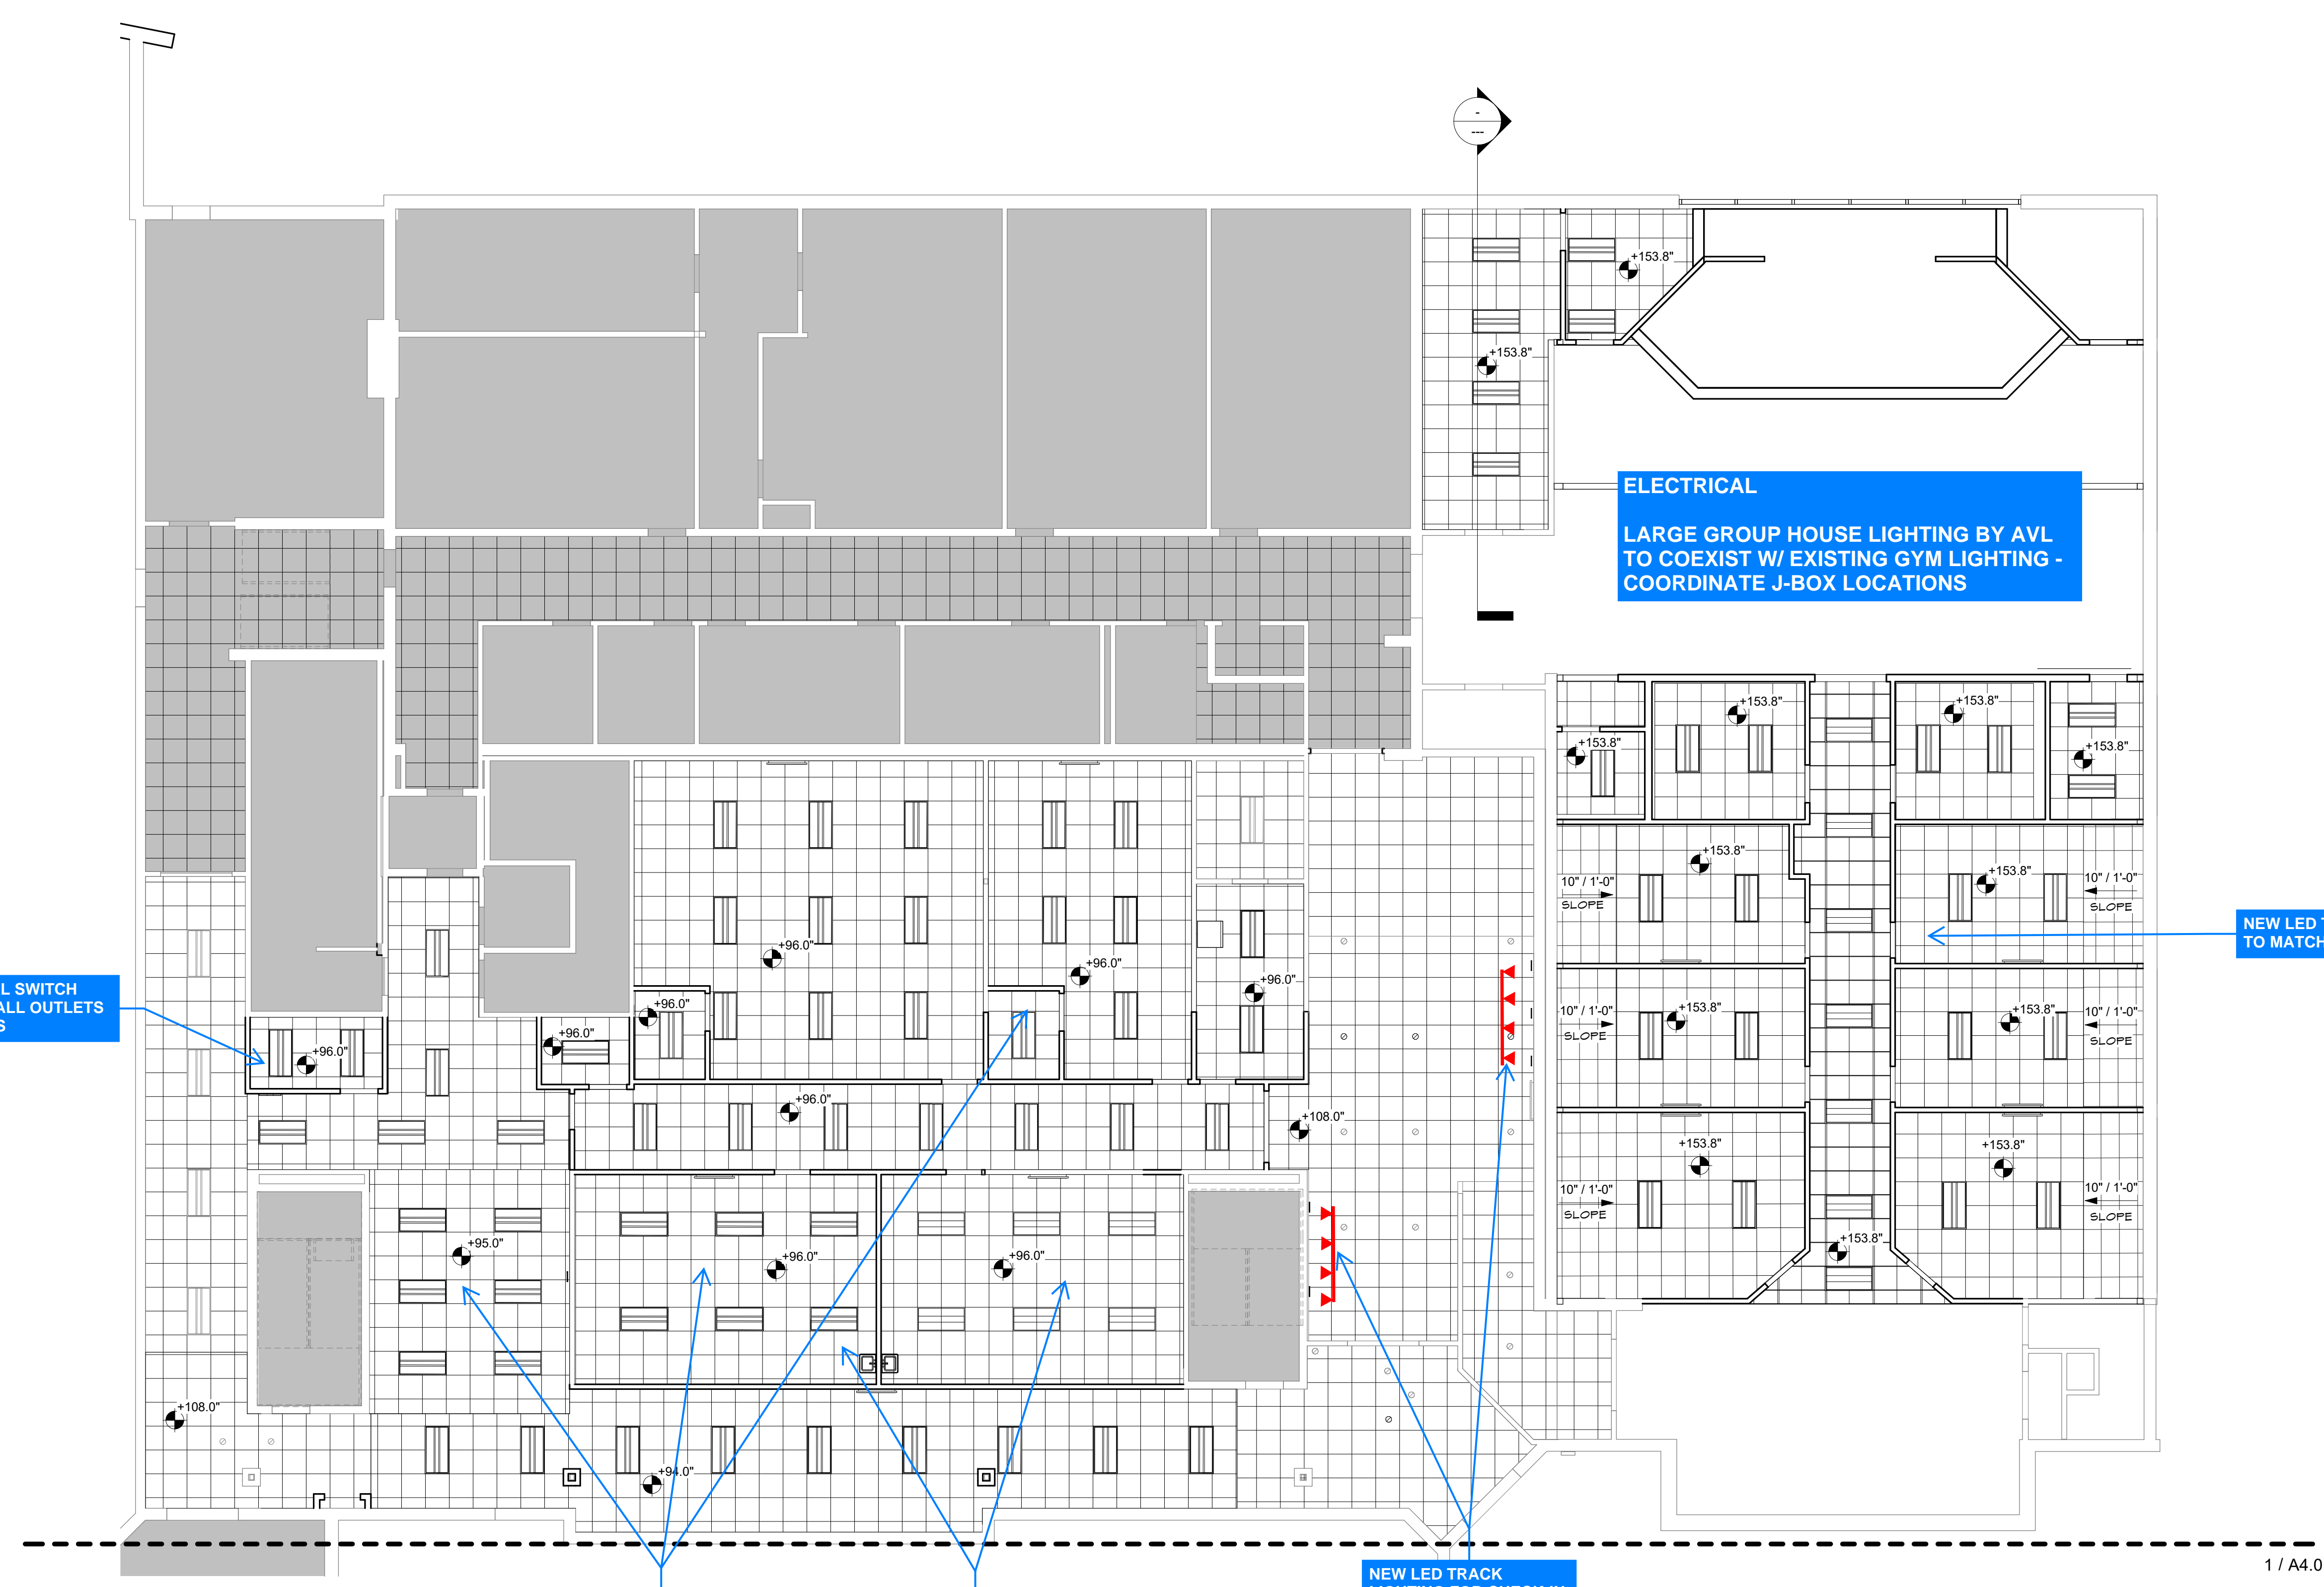

1 / A4.0

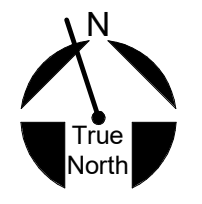

RCP LEGEND

- LIGHTING**
- RECESSED CAN (LED)
 - ⊙ SUSPENDED PENDANT (LED)
 - 1X4 FIXTURE (LED)
 - ▨ 2X2 RECESSED (LED)
- CEILING**
- OPEN CEILING TO STRUCTURE ABOVE
 - ▨ DRYWALL
 - ▨ SMOOTH TEXTURED EIFS OVER 1/2" THK DENS GOLD SUBSTRATE 1/2" THK CEMENT BOARD SUBSTRATE, TYP. @ OUTSIDE SOFFIT CONDITION
 - ▨ EXTERIOR CONDITION SMOOTH TEXTURED EIFS OVER 1/2" THK DENS GOLD SUBSTRATE 1/2" THK CEMENT BOARD, TYP. @ OUTSIDE SOFFIT CONDITION
 - ▨ MFG. ARMSTRONG 24" X 24" DUNE, REGULAR SUSPENSION GRID: 15 / 16" PRELUDE/WHITE
 - ⊗ 6' X 8' SUSPENDED CLOUDS @ VARIOUS HEIGHTS / ARMSTRONG FORMATIONS / WOODWORKS TILE AND AXIOM PERIMETER TRIM
 - ⊗ INDICATES CEILING HEIGHTS
 - ⊗ INDICATES PAINT
 - ⋯ INDICATES SOUND ATTENUATION
- MECHANICAL/ HVAC**
(FOR REFERENCE ONLY - REFER TO MECHANICAL DRAWINGS FOR SPECIFIC INFORMATION)
- ⊗ SUPPLY AIR REGISTER
 - ⊗ RETURN AIR REGISTER
 - ⊗ EXHAUST AIR REGISTER
 - ⊗ SPEAKER AND CONTROL, REFER TO AUDIO/VIDEO PLANS
- EXIT SIGNS**
- ⊗ WALL/CEILING MOUNTED EXIT SIGN ABOVE DOOR (SEE ELECTRICAL - TYPICAL) PER SECT. 1019.1.1.2015 BC
 - ⊗ ALUMINUM STOREFRONT MOUNTED EXIT SIGN (SEE ELECTRICAL DRAWINGS - TYPICAL) PER SECT. 1019.1.1.2015 BC

RCP SPECIFICATIONS

RCP GENERAL NOTES

1. SUSPENDED CEILING SYSTEM - TYP. GRID SYSTEM. REFER TO RCP DETAIL SHEET
2. LOCATE ALL LIGHTING FIXTURES AS SHOWN ON PLAN. ALIGN AT SOFFITS OR ROOMS AND PLACE EQUALLY SPACED AS SHOWN. REFER TO ELECTRICAL PLANS FOR ADDITIONAL INFORMATION.
3. ALL OPEN CEILINGS TO BE PAINTED (COLOR CHOSEN BY ARCHITECT), TO INCLUDE ALL SURFACES, EXPOSED CONDUIT, FIRE SPRINKLER LINES, AIR DUCTS, SUPPLY AND RETURN AIR GRILLES, ETC. STARTING AT THE BOTTOM OF LOWEST STRUCTURAL ELEMENT (UNLESS OTHERWISE NOTED). SEE PAINT SCHEDULE.
4. LOCATE ALL LIGHTING FIXTURES AS SHOWN, AND PER DIMENSIONS ON PLANS. COORDINATE WITH CONSTRUCTION DOCUMENTS FROM ASSOCIATED DISCIPLINES.
5. THEATRICAL/STAGE LIGHTING IN SANCTUARY/ASSEMBLY ROOMS TO BE SELECTED AND LOCATED BY AUDIO VISUAL CONSULTANT AND ELECTRICAL ENGINEER. COORDINATE WITH ALL DISCIPLINES BEFORE CONSTRUCTION.
6. REFER TO INTERIOR DESIGN PLANS FOR ADDITIONAL INFORMATION REGARDING PAINT, FINISH MATERIALS, ETC.

RCP KEY NOTES



Seal

Consultant

**NORTH ROANOKE BAPTIST CHURCH
FACILITY RENOVATION**
6402 PETERS CREEK ROAD | ROANOKE, VA 24019

REFLECTED CEILING PRE-K/KIDS

SHEET ISSUE & REVISION		
#	DATE	DESCRIPTION

DESIGN TEAM	
Designed By	CC
Drawn By	TEAM
Checked By	BM
Approved By	BM

Project No. 23614
Date 06/06/23

Project Status
SCHEMATIC DESIGN

Sheet Name
REFLECTED CEILING
PRE-K/KIDS

Sheet No.
A4.1